



Slab details

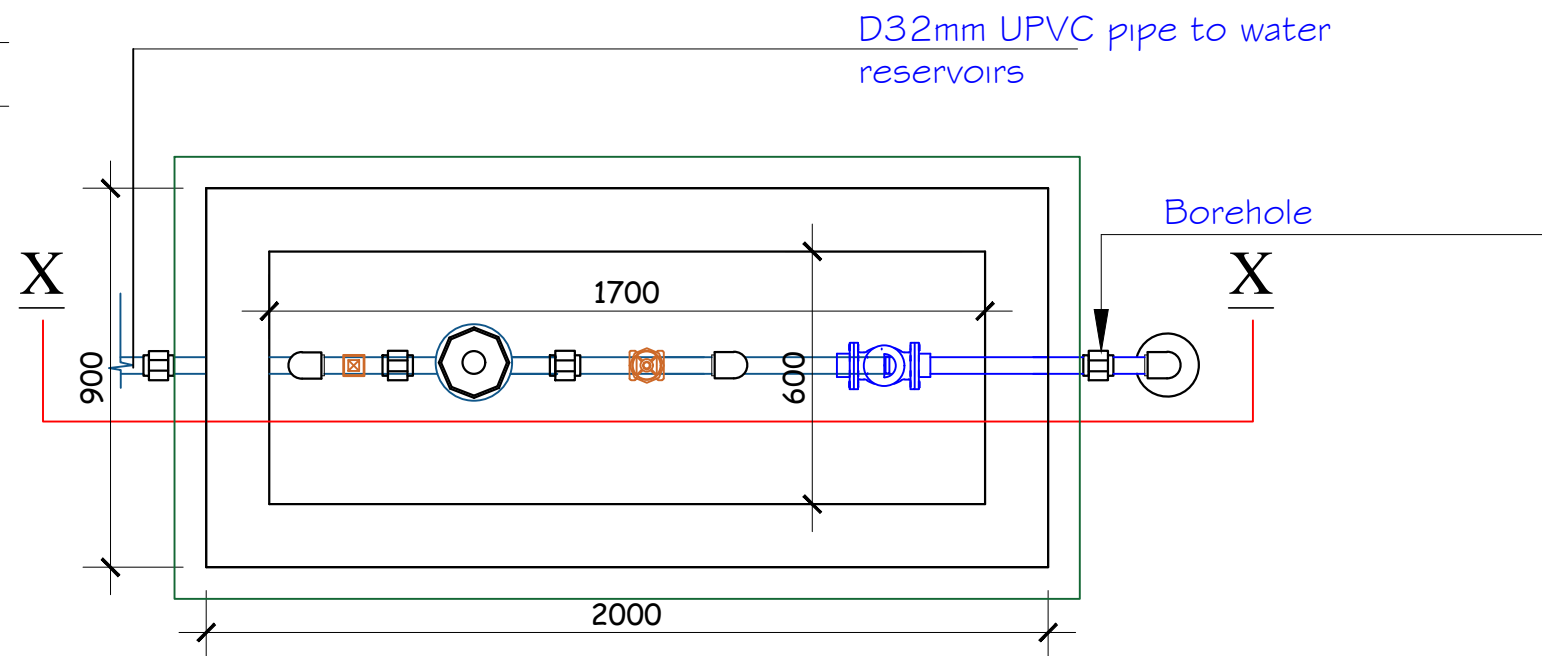

Floor Plan

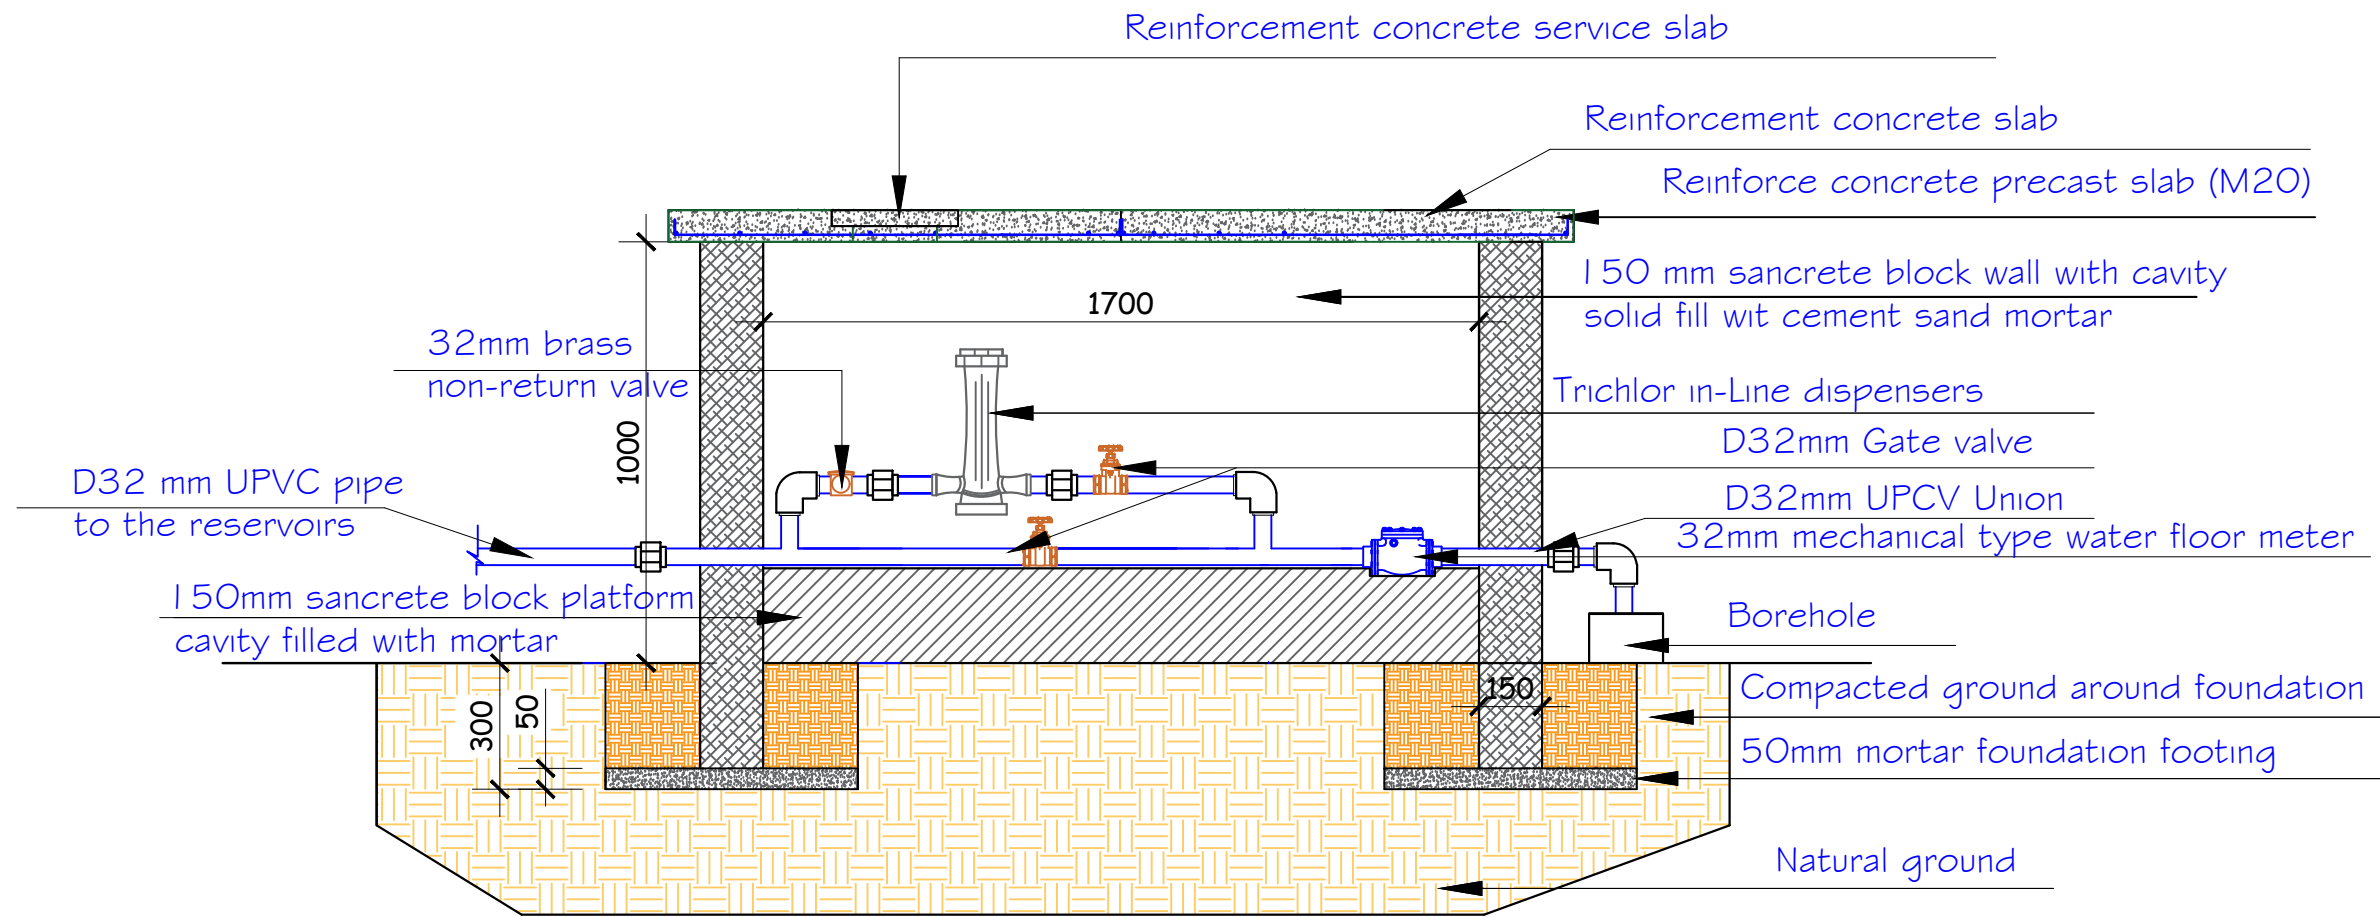

Section X-X

NOTES:

1. All dimensions are in millimeters
2. All dimensions are to be verified on site and approved by MC technical personnel

Title:
Chlorine feeder Protection
Details

Project:
Water Supply-Borehole Upgrading

UTILITY DRAWING

DRWG No.:

ARCH-1a

Desing: Harun Kobia
Mburugu
Drawn: Emmauel
Chimda Solomon